



CONTINUATION FROM DRAWING NUMBER ST023_0134-001-DWG-PIP-Y01-014

DRL No. ST023_0134-001-DWG-PIP-Y01-015

- NOTES**
- ALL DIMENSIONS IN MILLIMETRES AND ALL LEVELS IN METRES UNLESS SHOWN OTHERWISE.
 - EXACT LOCATION OF AIR VALVE, WASHOUT AND MANHOLE CHAMBERS TO BE CONFIRMED.

- REFERENCES**
- ST023_0134-001-DWG-PIP-Y01-012 PROPOSED SITE PLAN - PIPE ROUTE 1 OF 4
 - ST023_0134-001-DWG-PIP-Y01-013 PROPOSED SITE PLAN - PIPE ROUTE 2 OF 4
 - ST023_0134-001-DWG-PIP-Y01-014 PROPOSED SITE PLAN - PIPE ROUTE 3 OF 4

- LEGEND**
- RED LINE BOUNDARY
 - PROPOSED AIR VALVE CHAMBER
 - PROPOSED WASHOUT CHAMBER
 - PROPOSED MANHOLE CHAMBER
 - - - - - PROPOSED PIPE ROUTE
 - - - - - COUNCIL BOUNDARY

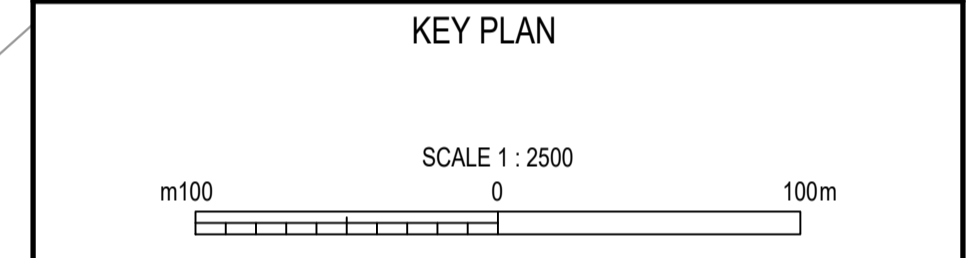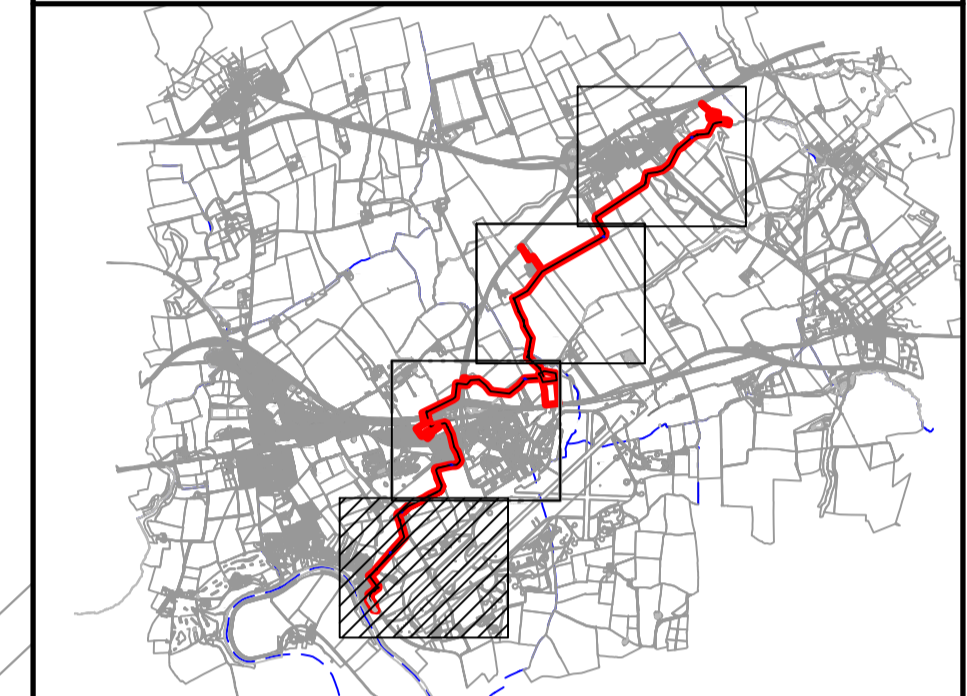

CURRENT VERSION INFORMATION

NO.	DATE	BY	DESCRIPTION	APPROVED BY	DATE	
P02	S2		FOR INFORMATION	DgH	LA LZ 19.12.2023	
P01	S2		FOR INFORMATION	PAB	LA LZ 31.10.2023	
REVISION	STATUS	SUITABILITY DESCRIPTION	AUTHORED	CHECKED	REVIEWED	DATE

NORTHUMBRIAN WATER GROUP
WINEP TEESIDE TRANSFER

PROPOSED SITE PLAN - PIPE ROUTE
4 OF 4

THIS DRAWING IS ISSUED BY STANTEC UK SUBJECT TO THE CONDITIONS THAT IT IS NOT COPIED EITHER IN WHOLE OR IN PART OR DISCLOSED TO THIRD PARTIES UNLESS PRIOR WRITTEN AUTHORISATION IS GIVEN BY STANTEC UK. PREVIOUS VERSIONS OF THIS DRAWING SHOULD BE STAMPED SUPERSEDED OR DESTROYED. DO NOT SCALE THIS DRAWING - IF IN DOUBT ASK.



CLIENT CONTRACT NO. ST023/0134	SCALE 1 : 2500	MASTER SIZE A1	STATUS S2
DRAWING NO. 331003043-STN-XX-XX-DR-T-0011			REVISION P02